




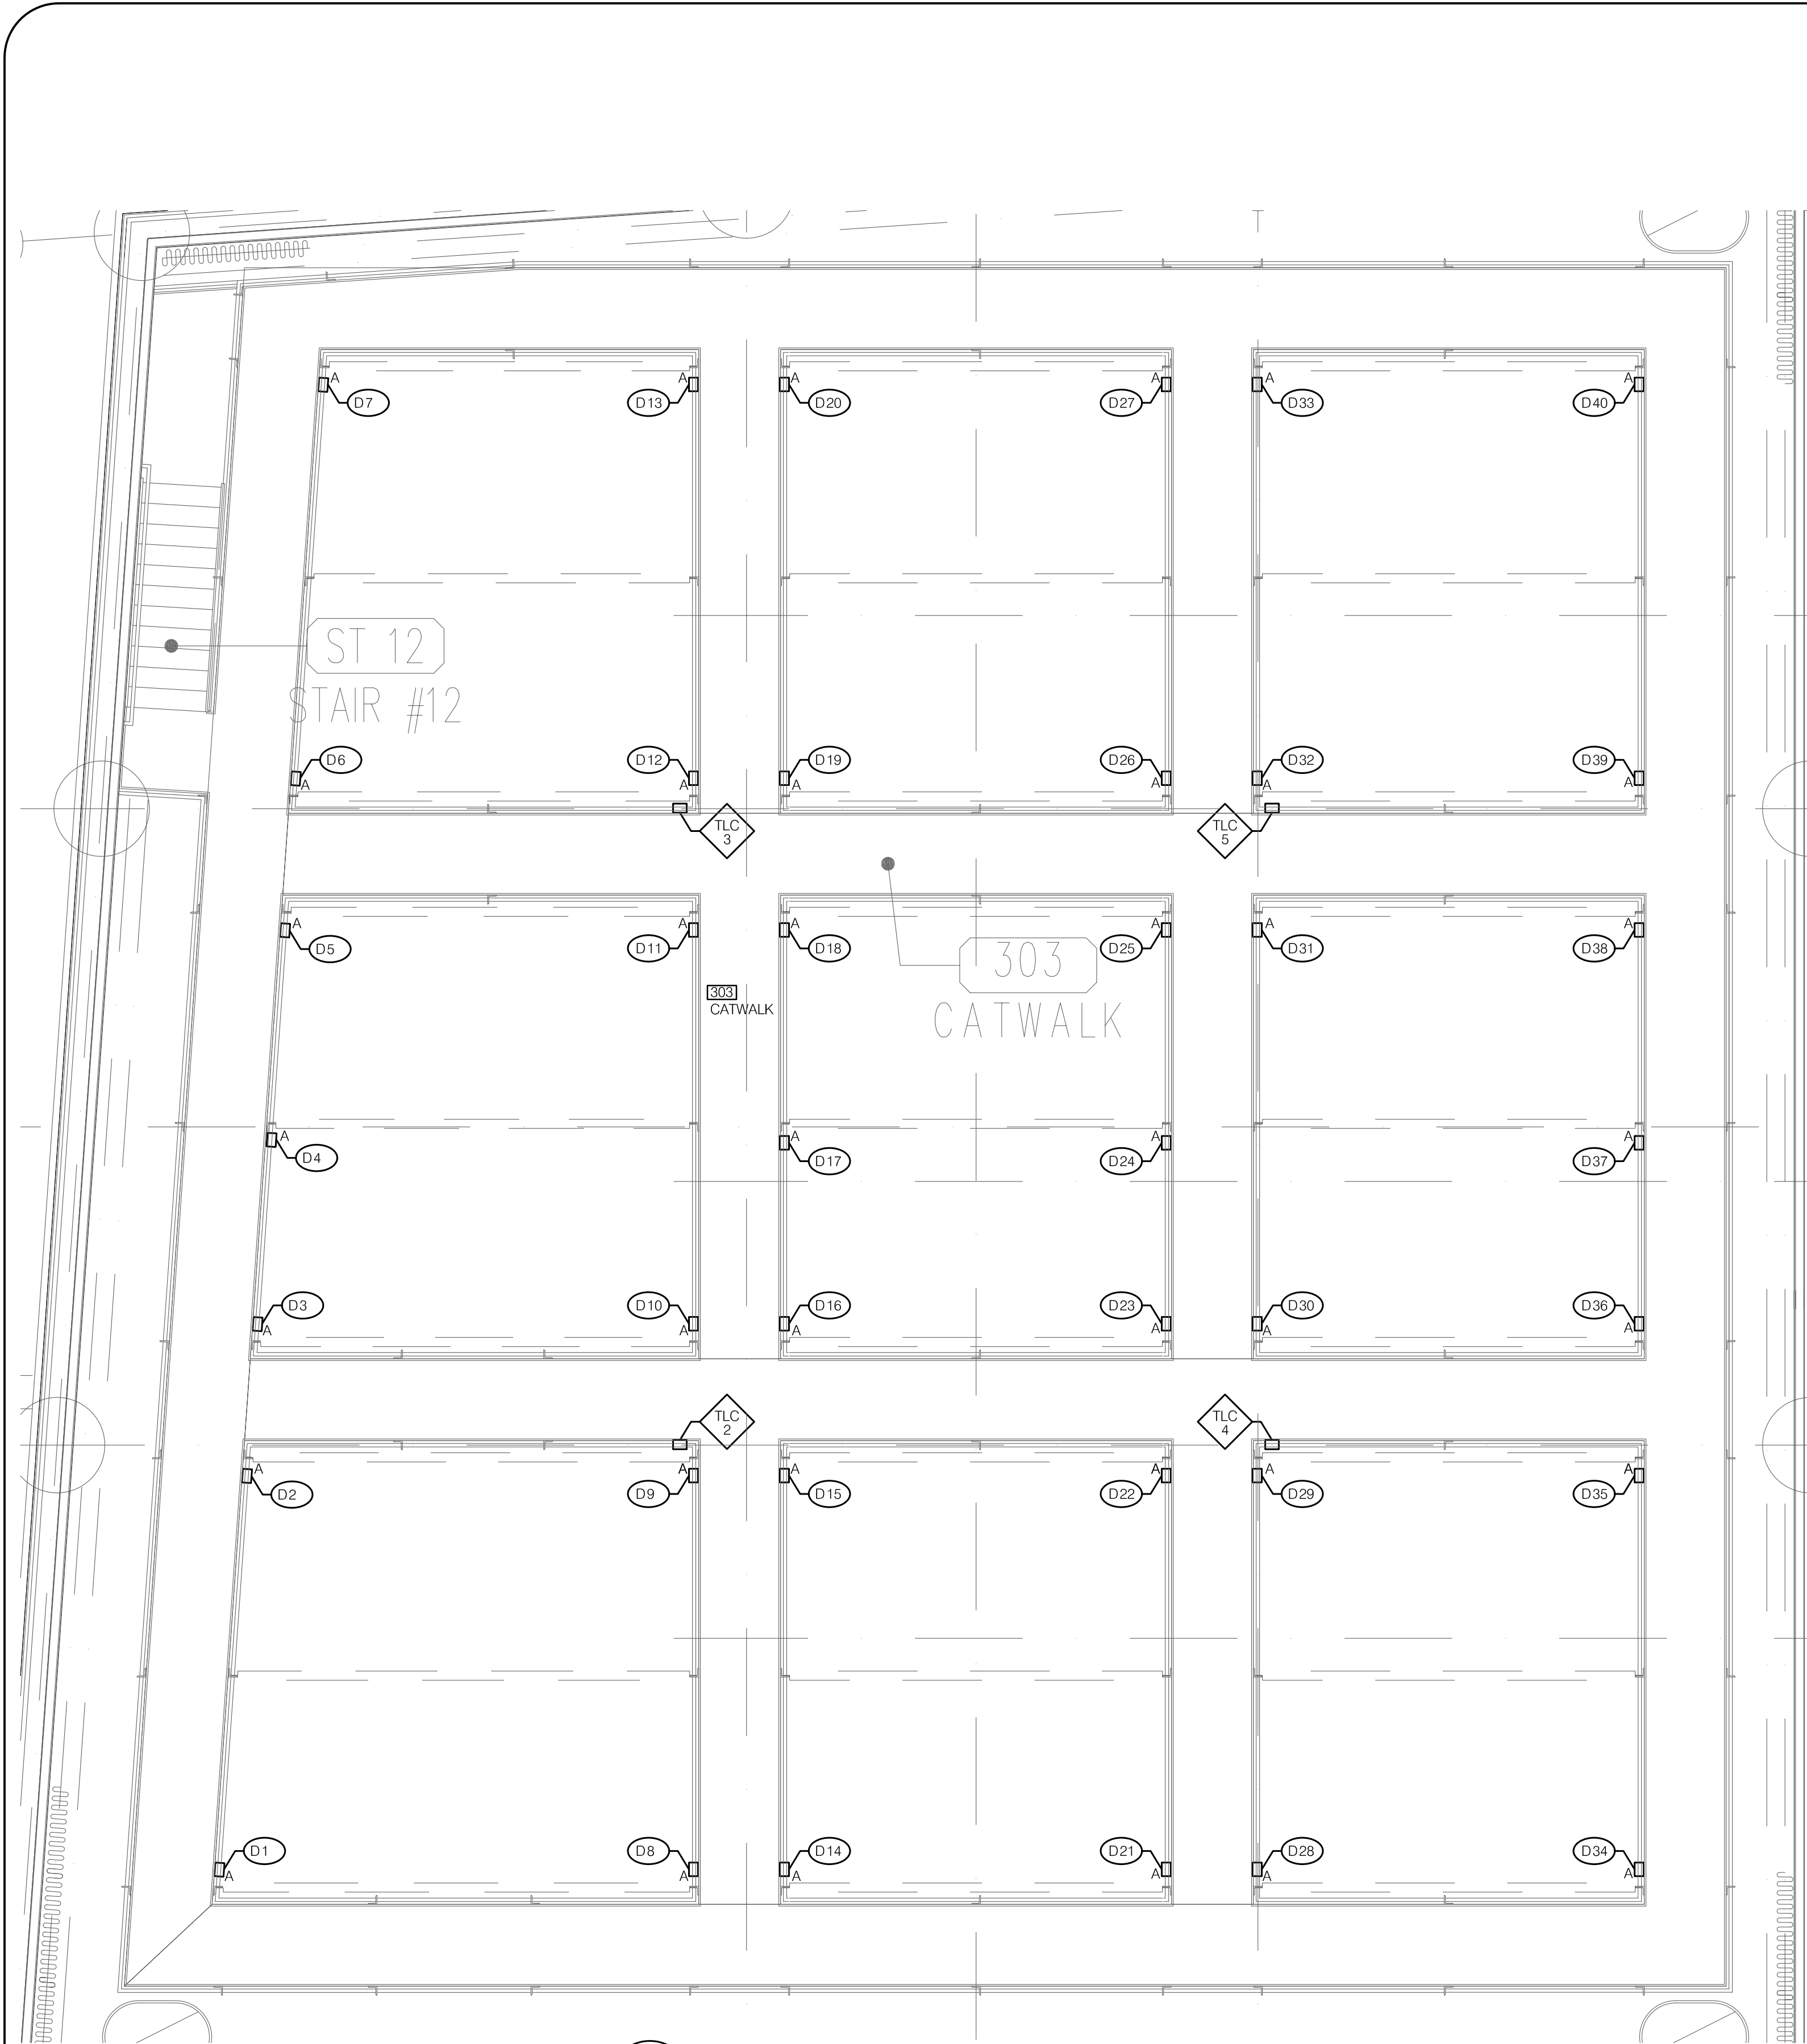


1 CATWALK LEVEL THEATER LIGHTING DEVICES
TE-1 SCALE: 1/4" = 1'-0"

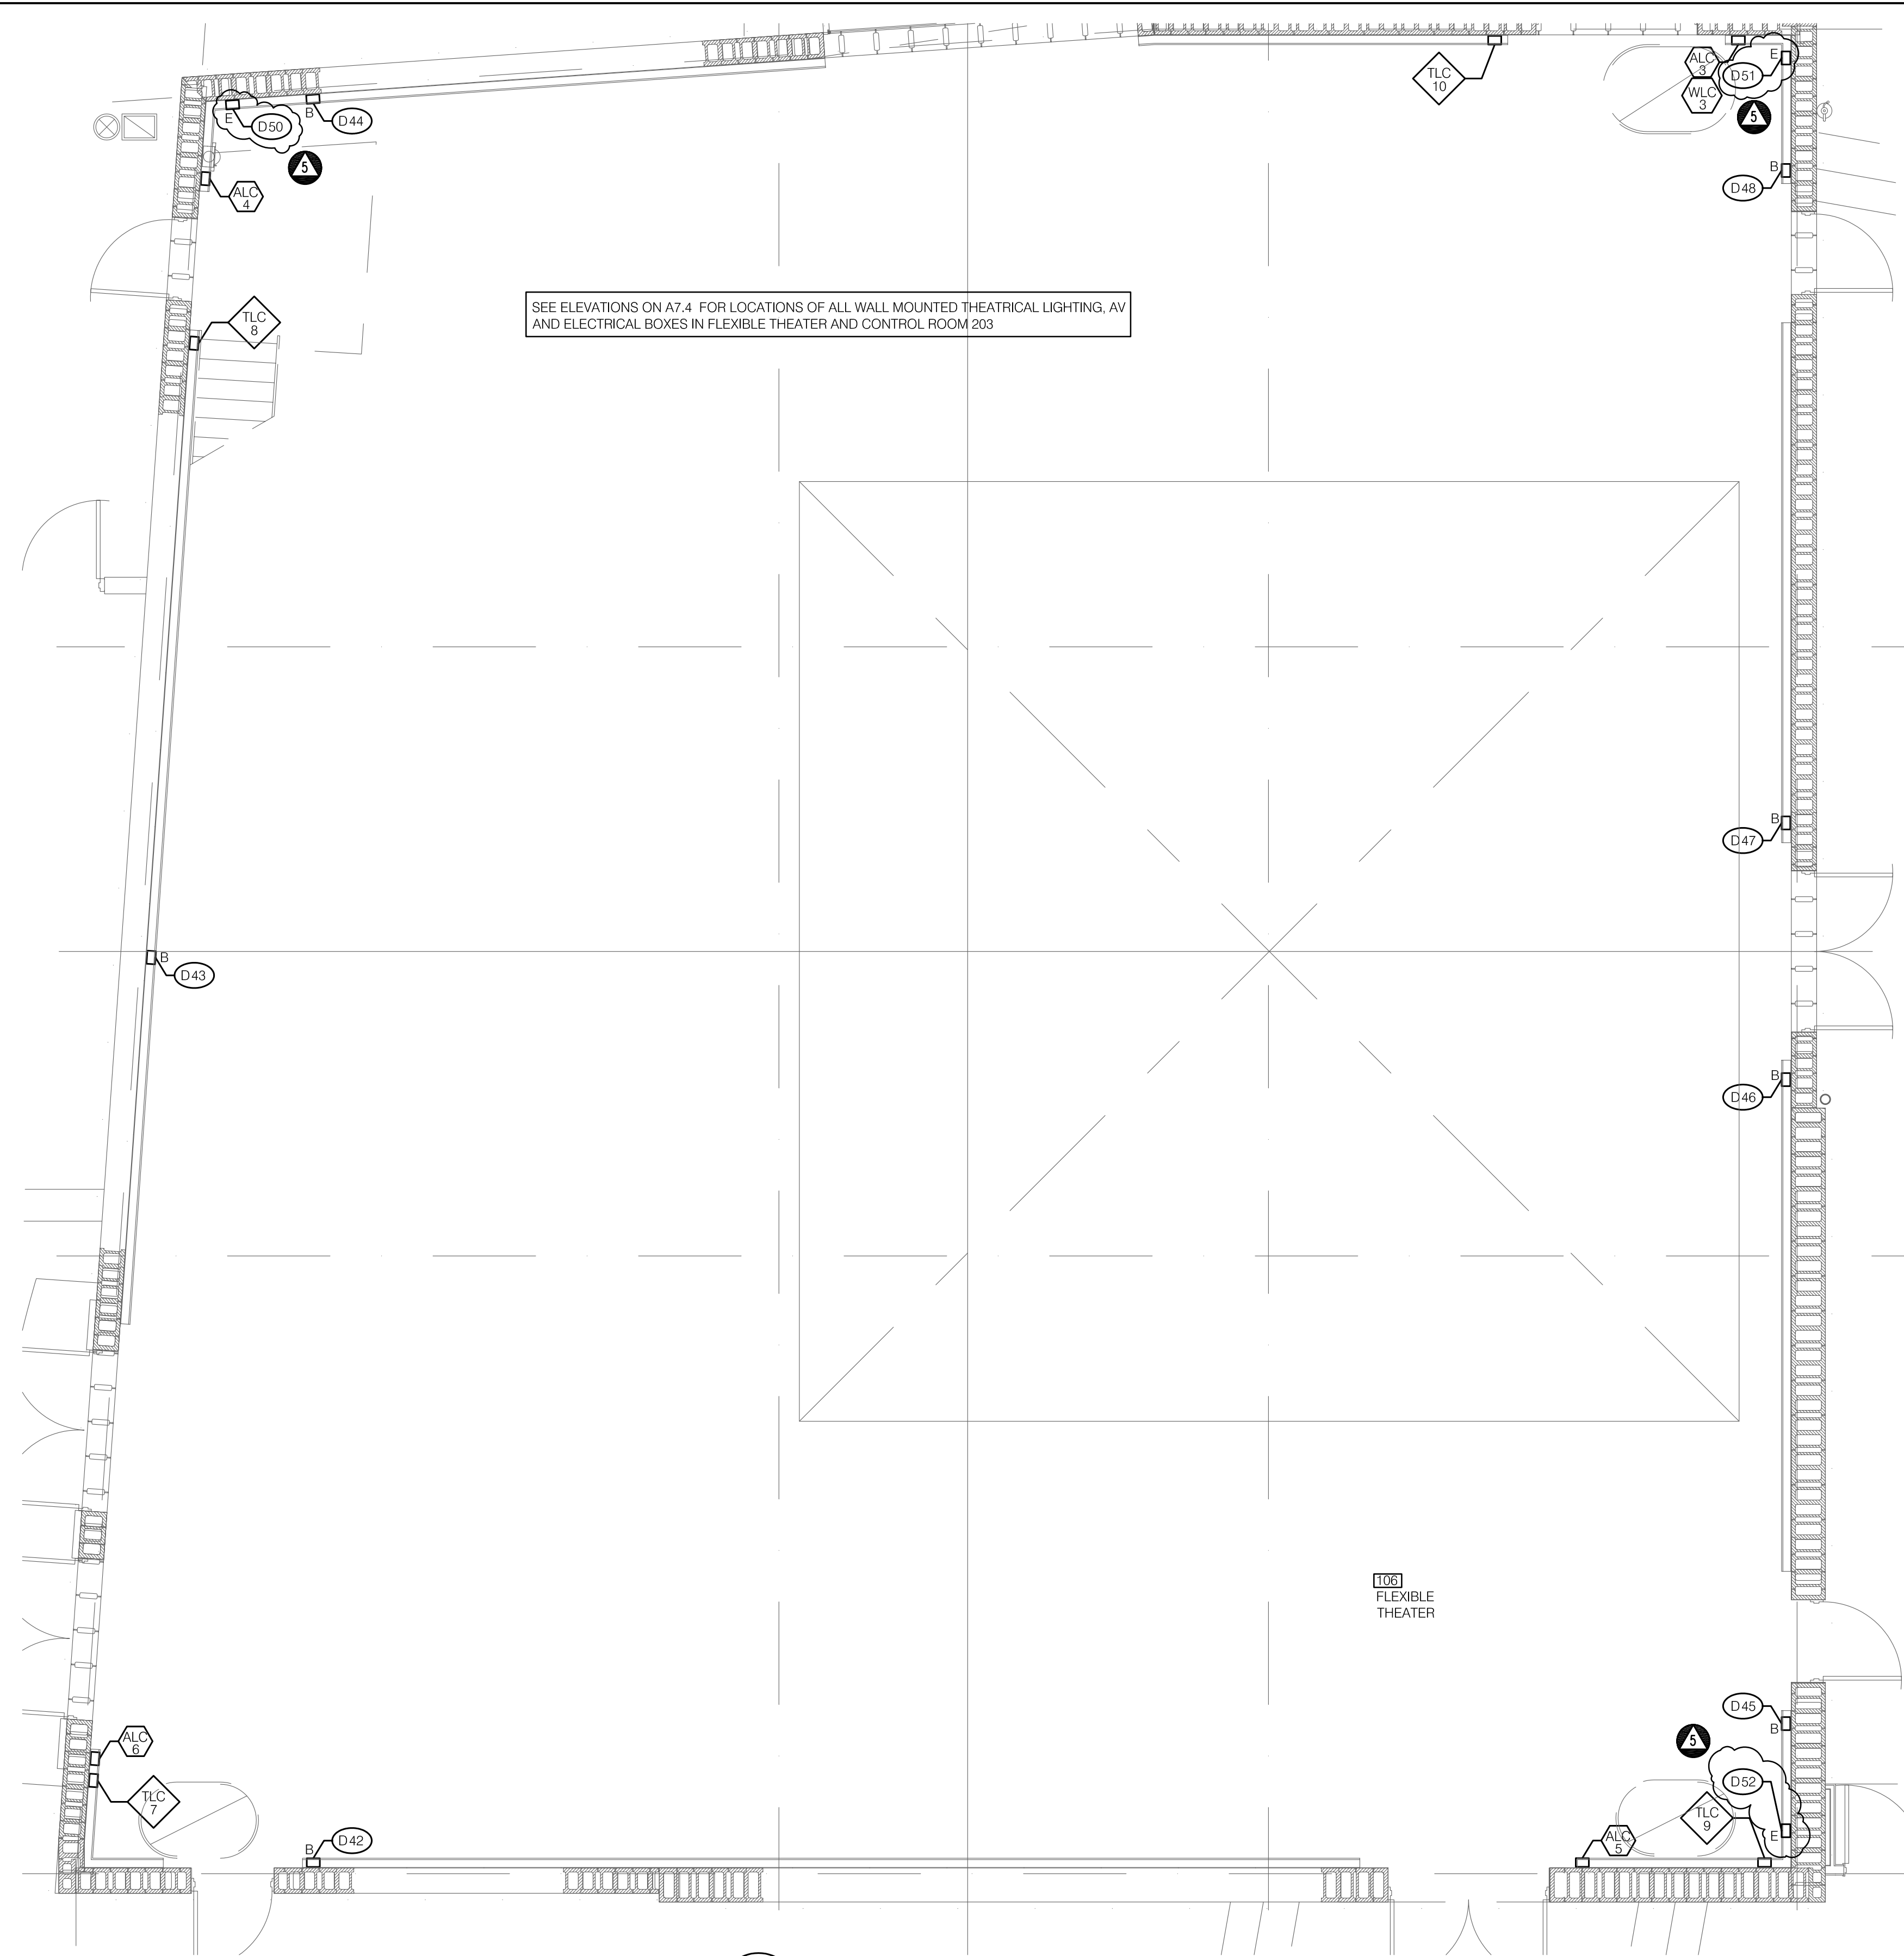


2 MAIN LEVEL THEATER LIGHTING DEVICES
TE-1 SCALE: 1/4" = 1'-0"

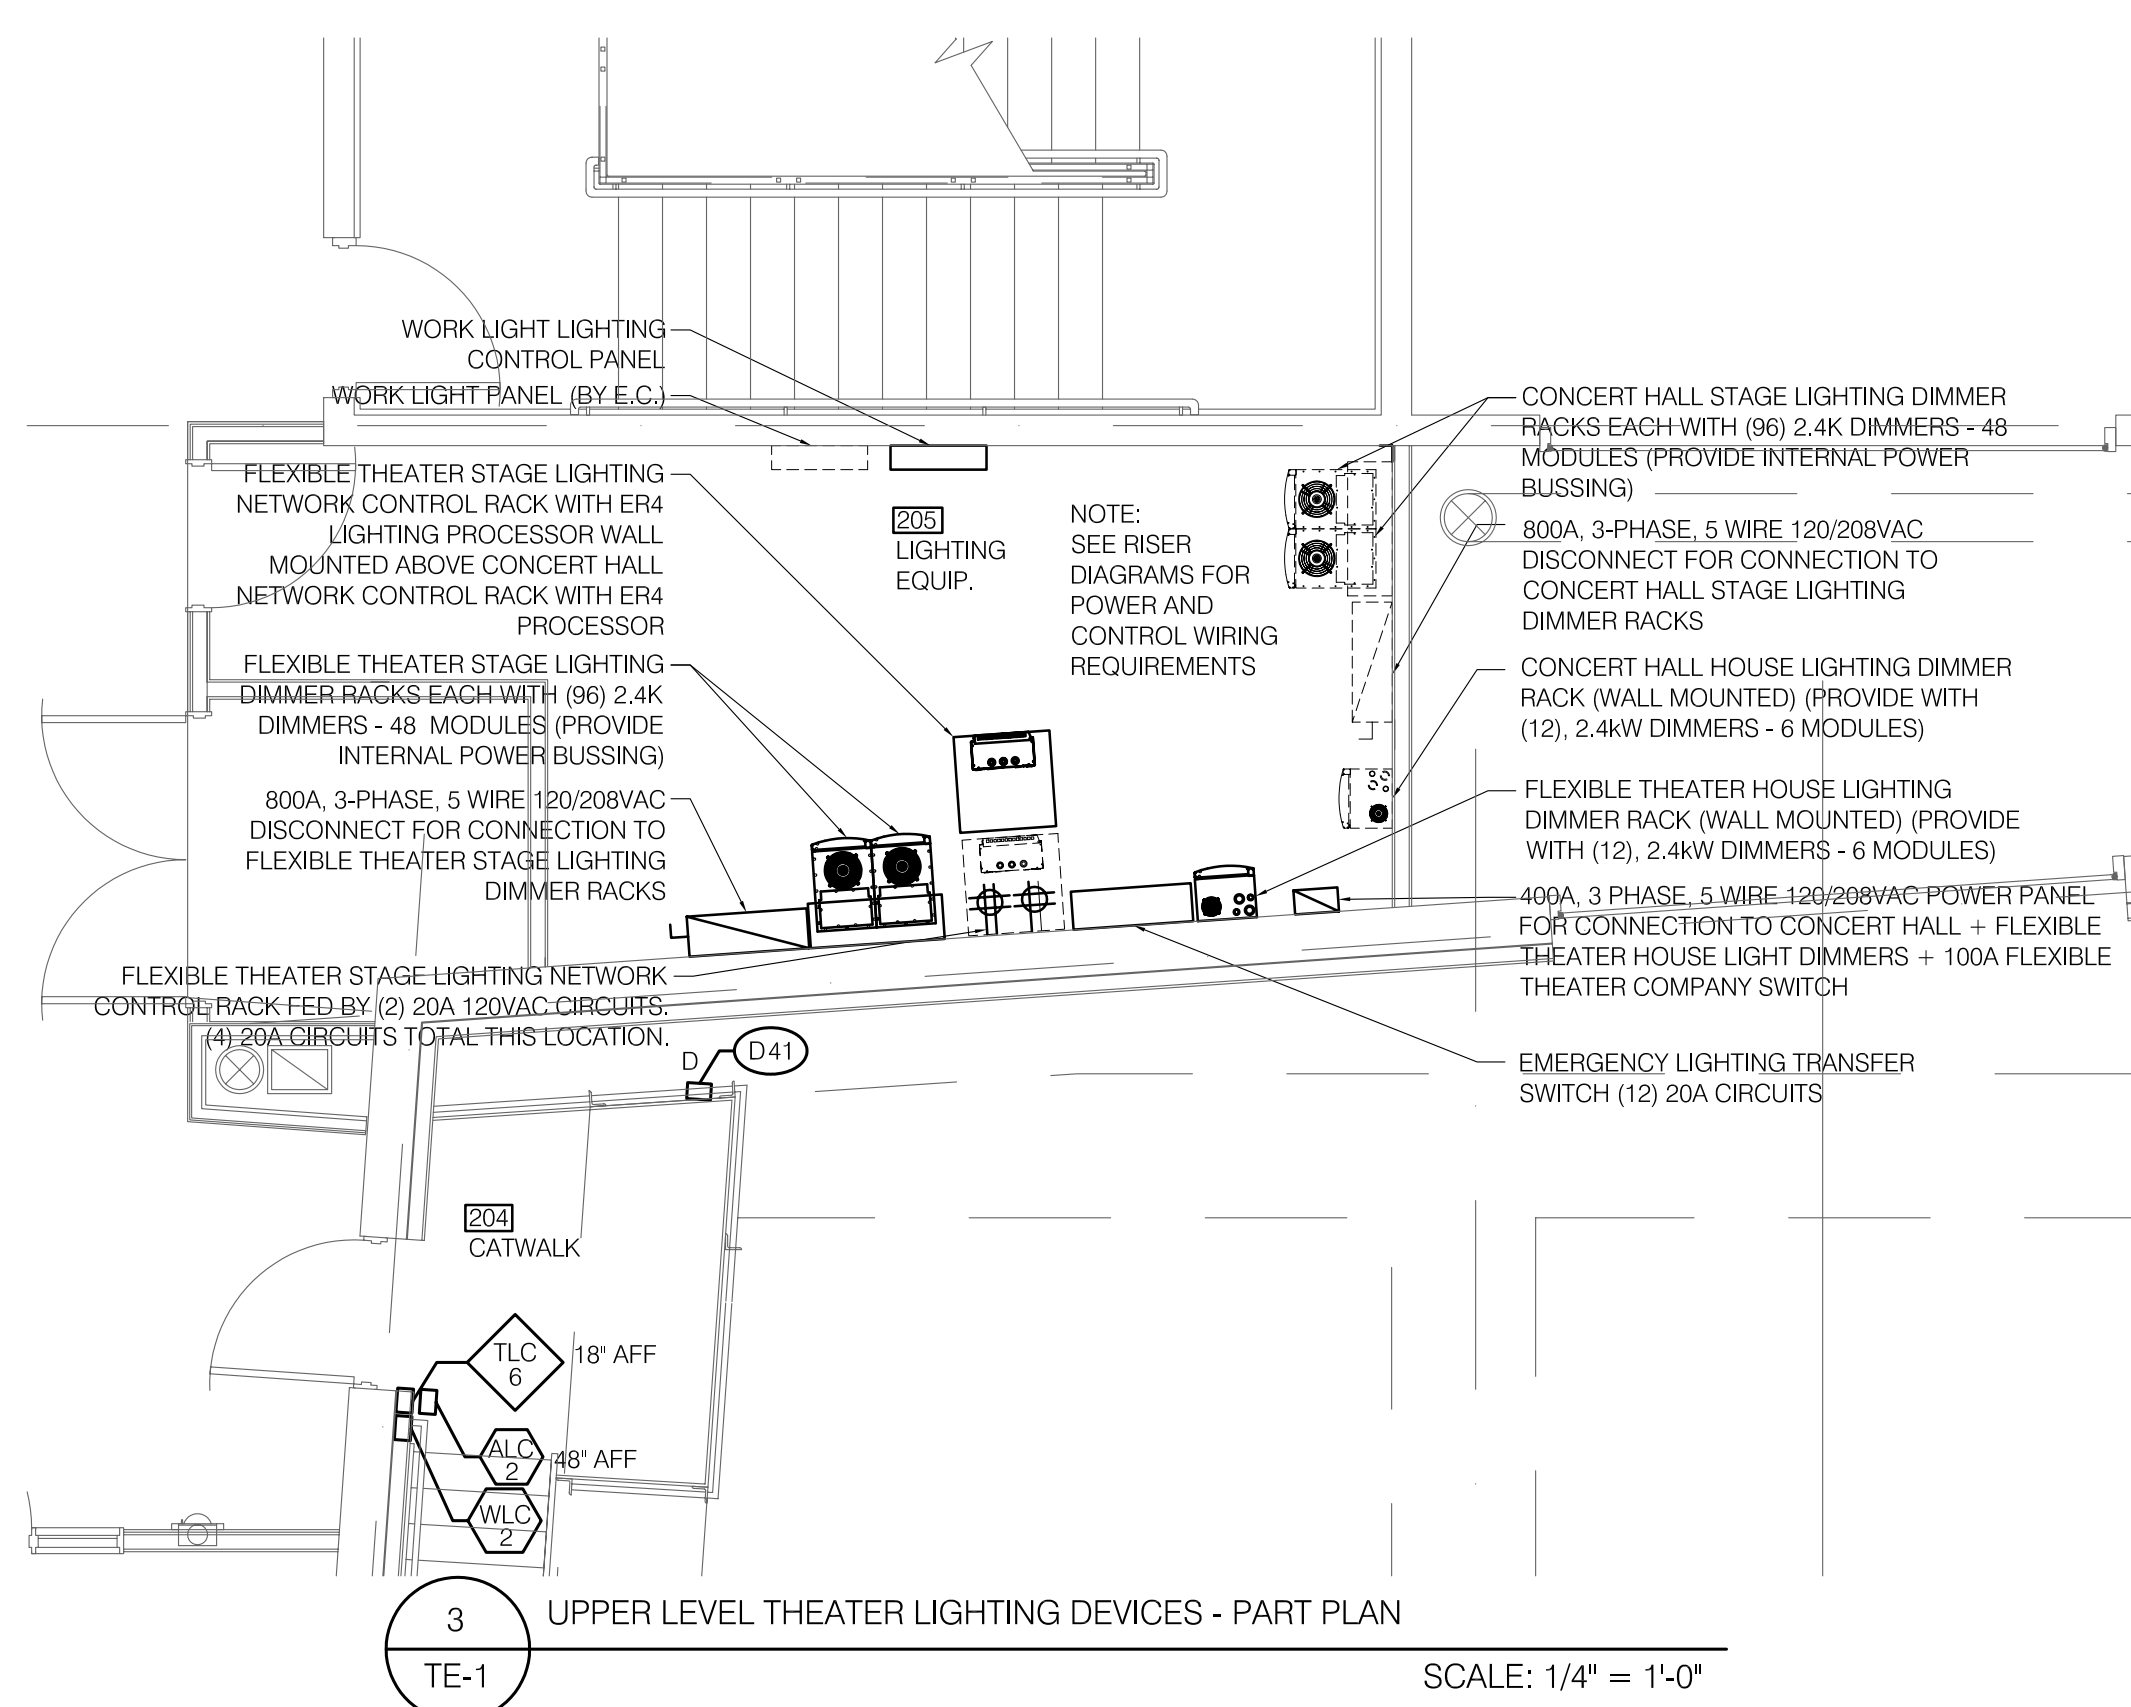


3 UPPER LEVEL THEATER LIGHTING DEVICES - PART PLAN
TE-1 SCALE: 1/4" = 1'-0"

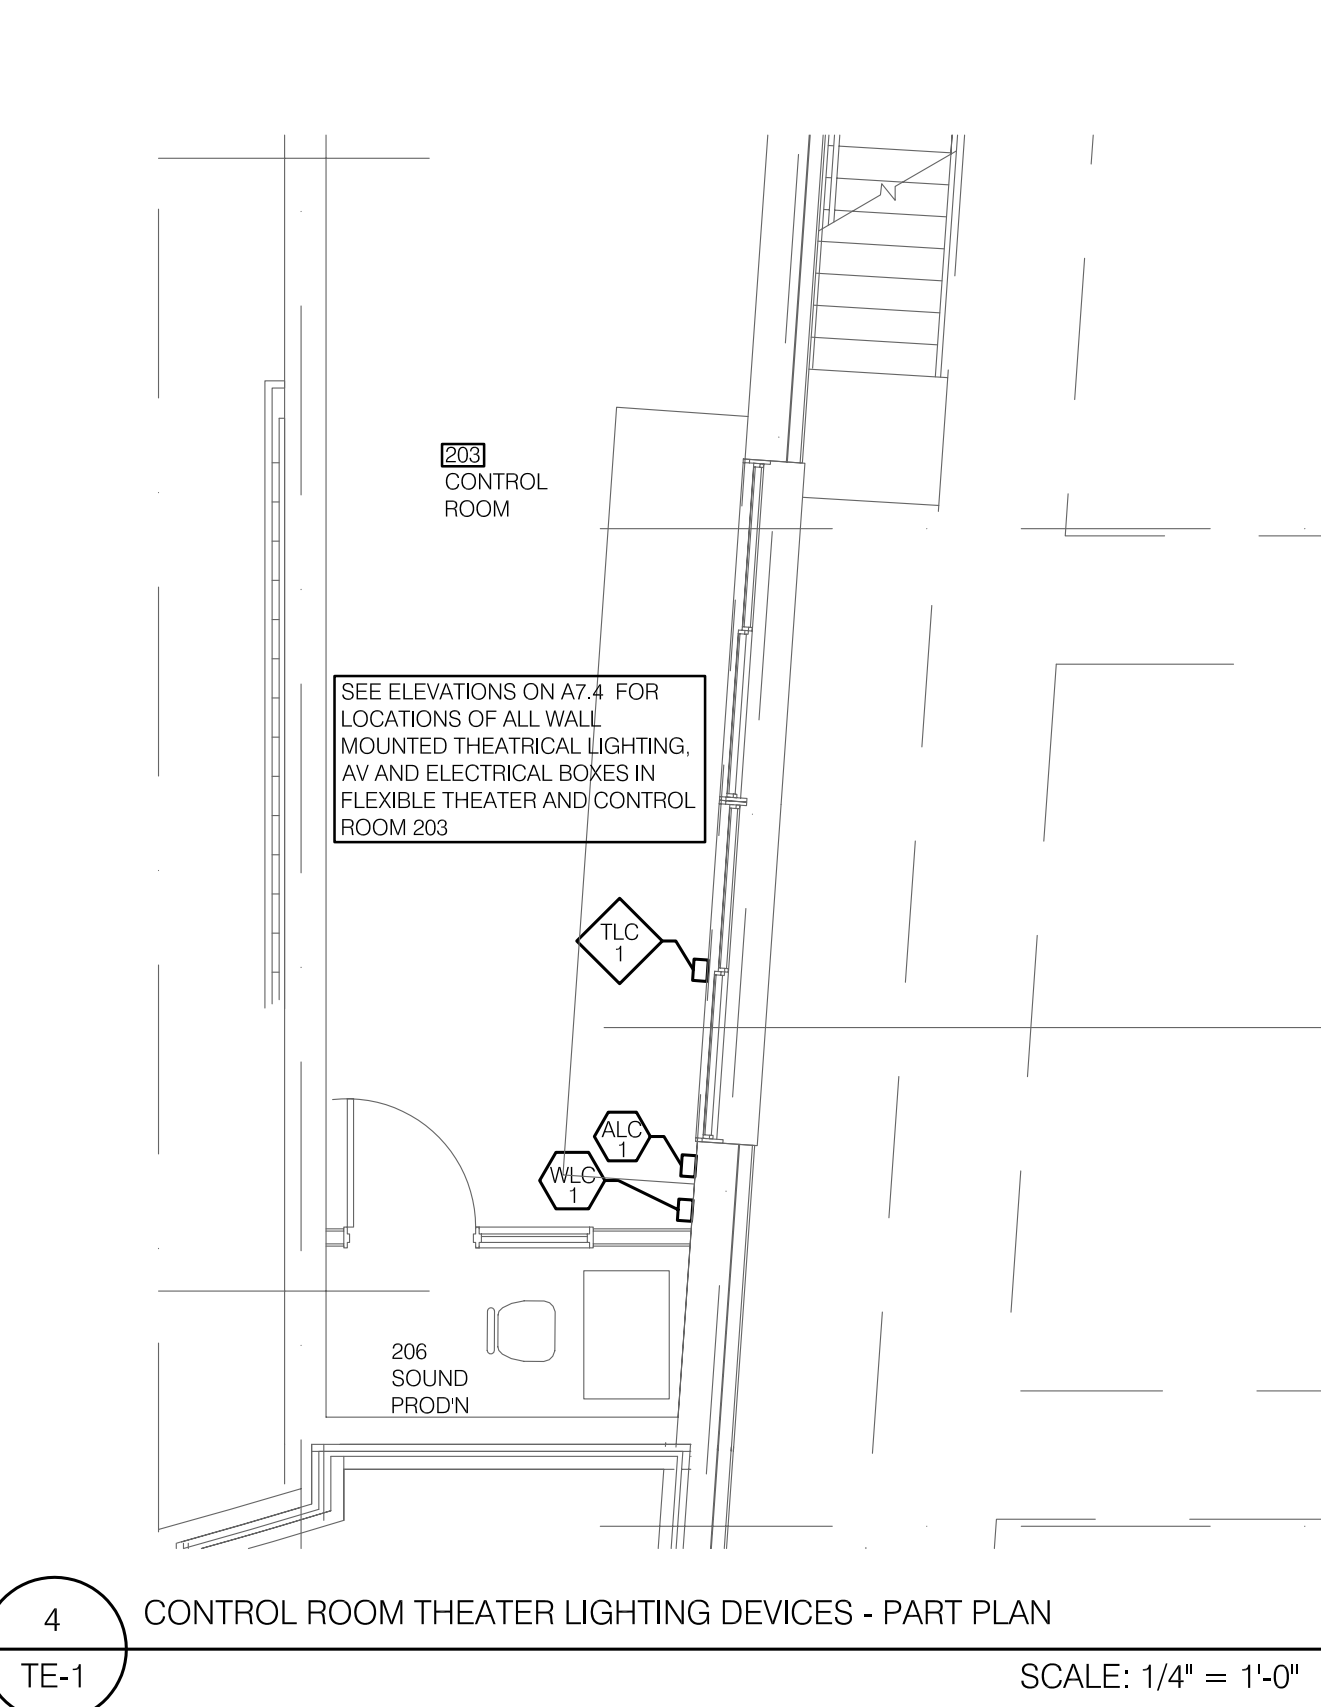

4 CONTROL ROOM THEATER LIGHTING DEVICES - PART PLAN
TE-1 SCALE: 1/4" = 1'-0"

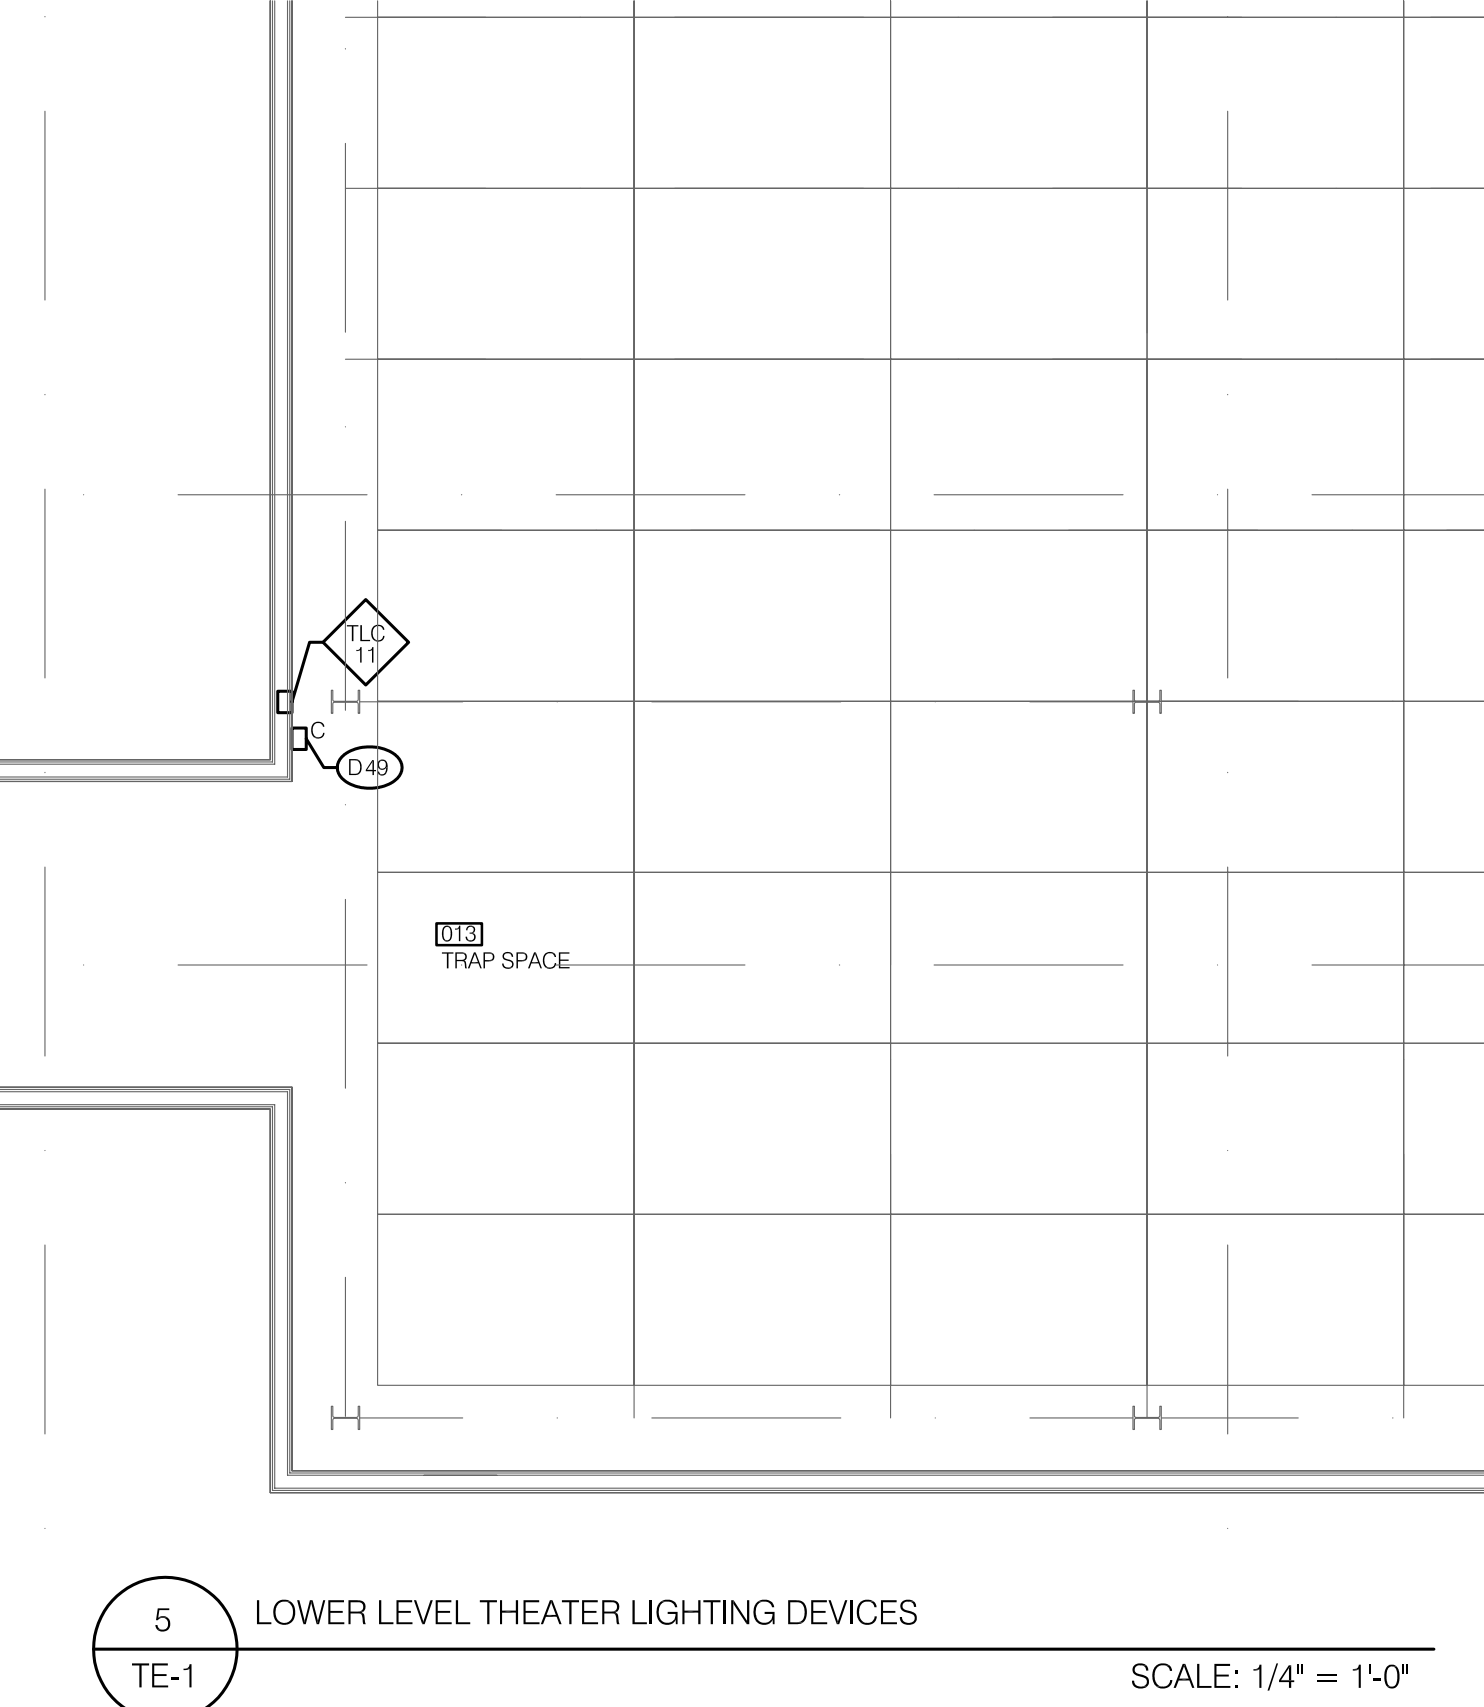

5 LOWER LEVEL THEATER LIGHTING DEVICES
TE-1 SCALE: 1/4" = 1'-0"

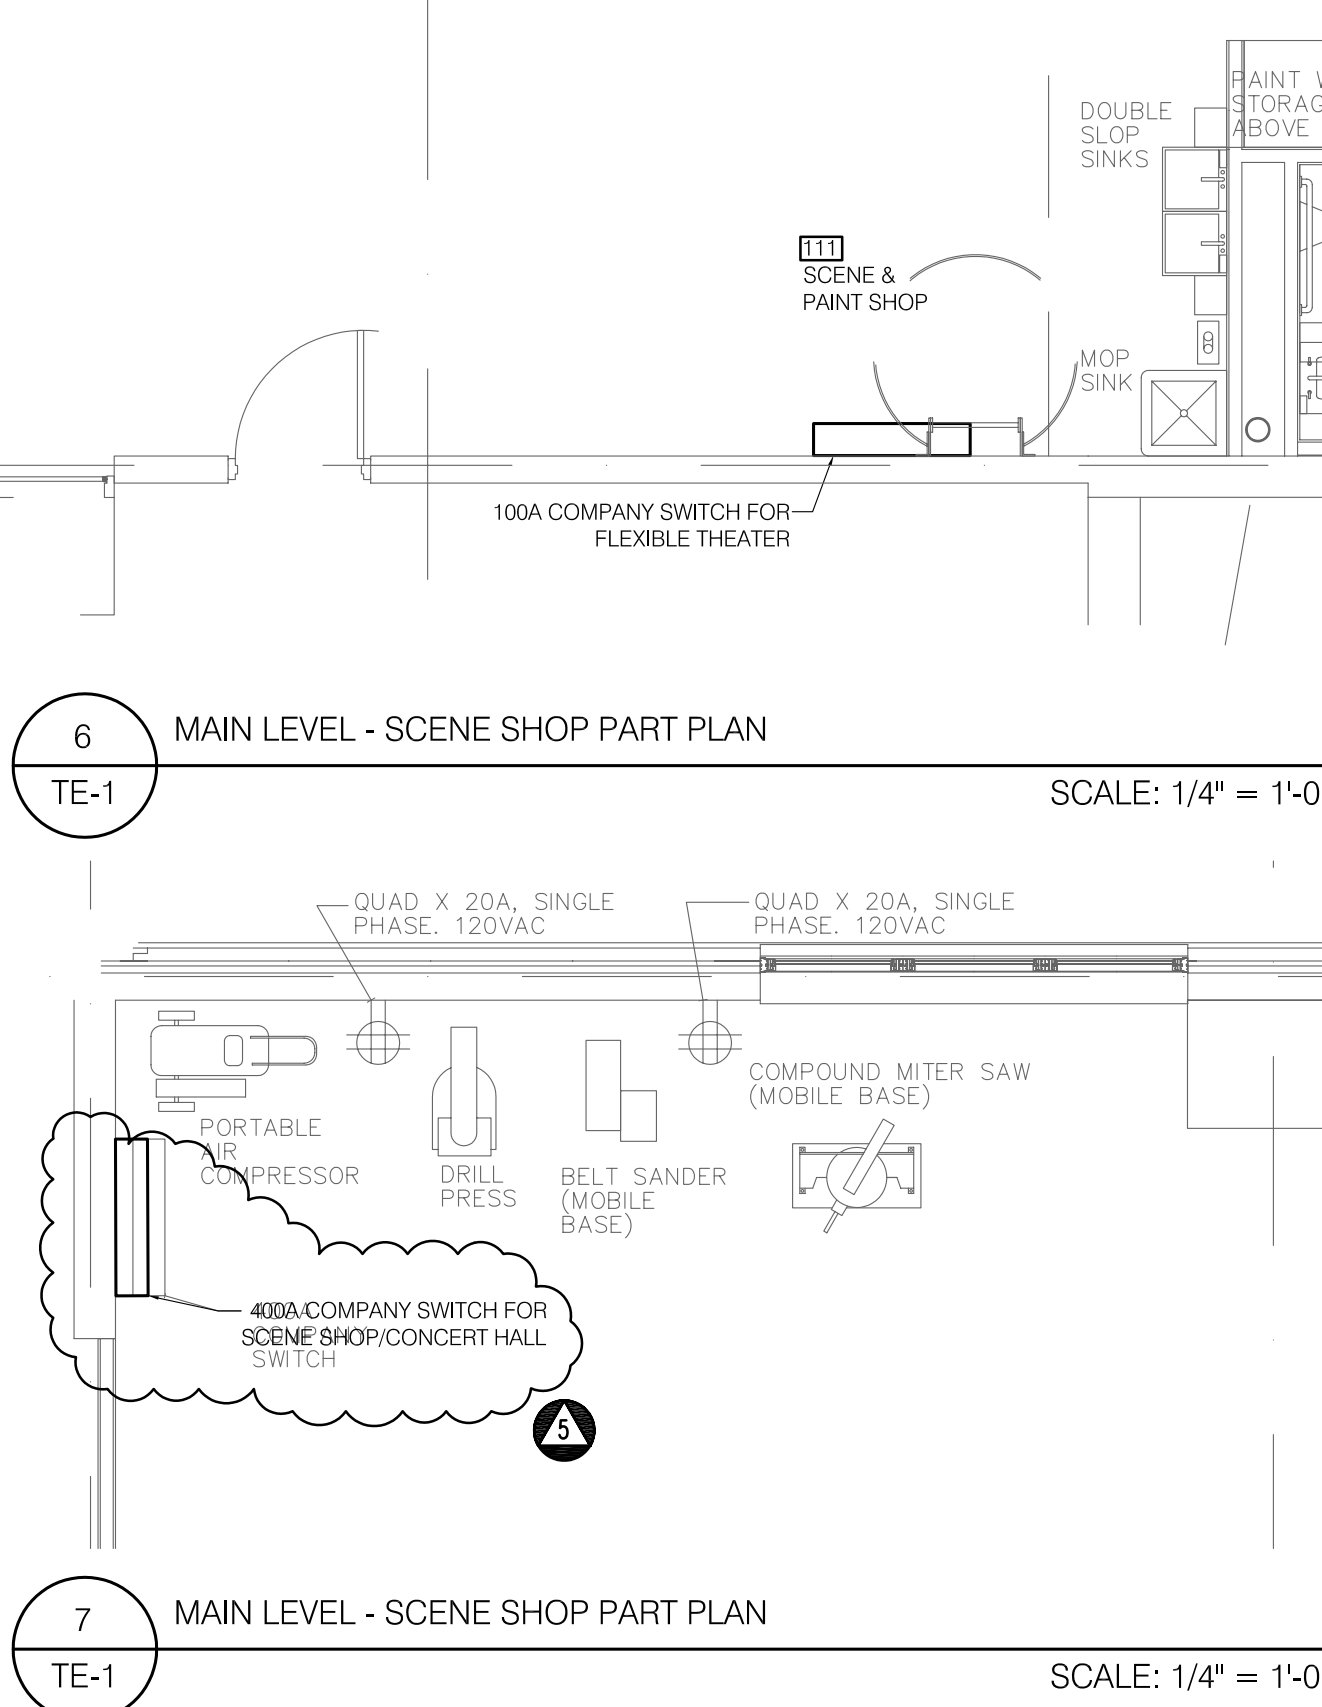

6 MAIN LEVEL - SCENE SHOP PART PLAN
TE-1 SCALE: 1/4" = 1'-0"

- ▲ APRIL 11, 2007 - REVISED AS PER CODE REVIEW
- ▲ JUNE 20, 2007 - REVISED IN ADDENDUM #2
- ▲ JUNE 25, 2007 - REVISED IN ADDENDUM #3
- ▲ JUNE 26, 2007 - REVISED IN ADDENDUM #4
- ▲ JUNE 27, 2007 - REVISED IN ADDENDUM #5
- ▲ JULY 3, 2007 - REVISED IN ADDENDUM #6
- ▲ JULY 8, 2007 - REVISED IN ADDENDUM #7

ISSUED FOR
CONSTRUCTION
AUGUST 10, 2007
ISSUED FOR BID
JUNE 1, 2007

**MacLachlan
Cornelius &
Filoni**
ARCHITECTS, INC.
200 THE BANK TOWER
PITTSBURGH, PENNSYLVANIA 15222
LMBA
HARVEY MARSHALL BERLING ASSOCIATES
173 WEST 81st STREET 1671 PARK ROAD, SUITE 20
NEW YORK, NY 10024 FT. WRIGHT, KY 41011
T: 212.874.0214 T: 859.426.5601
F: 212.874.1482 F: 859.426.5789

**SETON HILL
UNIVERSITY**
UNIVERSITY
CENTER
HARRISON AVENUE
GREENSBURG, PA. 15601
CONTRACT NO. 530608 DATE 1 JUNE 2007

FLEXIBLE THEATER
THEATER LIGHTING PLANS
TE-1